



Republic of the Philippines  
DEPARTMENT OF AGRICULTURE  
Regional Field Unit No. 5  
San Agustin, Pili, Camarines Sur

**Project Title** : REPAIR OF POWER HOUSE  
**Location** : SDPTC, CABID-AN, SORSOGON CITY  
**Estimated Cost** : 700,000.00  
**Implementation** : By Contract  
**Subject** : Bill of Materials / Cost Estimates  
**Fund** :


SCOPE OF WORK

- 1) REMOVAL AND REPLACEMENT OF ENTIRE ROOFING & CEILING
- 2) RESTORATION OF ELECTRICAL WIRING
- 3) REPAINTING OF INTERIOR & EXTERIOR WALLS
- 4) REMOVAL AND REPLACEMENT OF ENTIRE DOORS & WINDOWS

Item	Descriptions	SUMMARY			Total Cost
I	: DISMANTLING WORKS	1.00	lot	=	
II	: CEILING WORKS	1.00	lot	=	
III	: ELECTRICAL WORKS	1.00	lot	=	
IV	: PAINTING WORKS	1.00	lot	=	
V	: ROOF & ROOF FRAMING WORKS	1.00	lot	=	
VI	: SCAFFOLDINGS WORKS	1.00	lot	=	
VII	: PLUMBING WORKS	1.00	lot	=	
VIII	: DOORS AND WINDOWS ( incl. All access. And grills )	1.00	lot	=	
IX	: METAL WORKS	1.00	lot	=	
		<b>EST. PROJEC EST. PROJECT COST</b>			<b>=</b>

\_\_\_\_\_  
NAME AND SIGNATURE OF CONSTRUCTOR



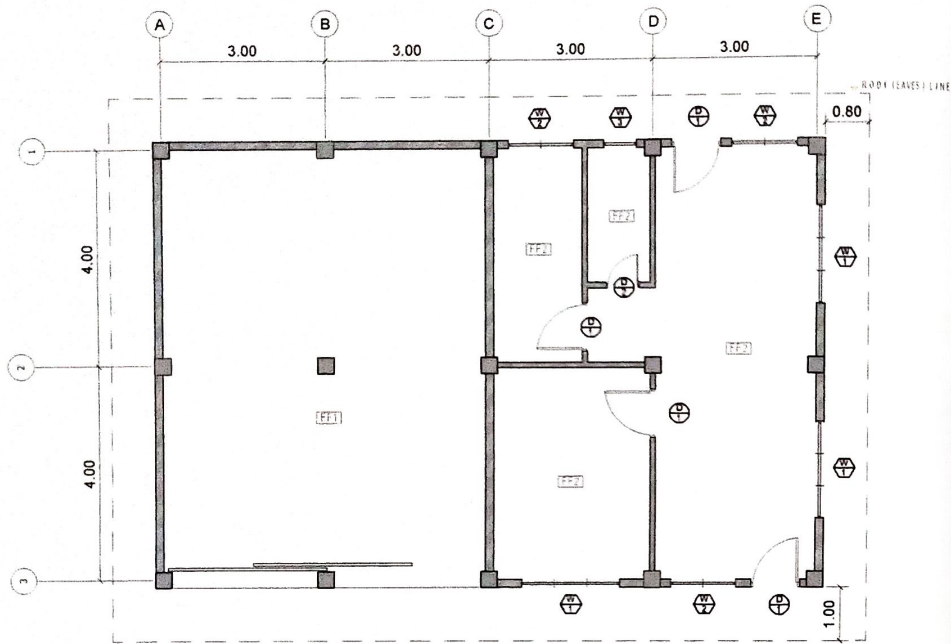

1  
A 1 FLOOR PLAN  
SCALE 1:100 M



2  
A 1 PERSPECTIVE VIEW  
NOT TO SCALE

**NOTE:**

- \* VERIFY ACTUAL SITE LOCATION FOR THE PROPOSED PROJECT CONSTRUCTION.
- \* USE D.A STANDARD COLOR COMBINATION FOR ALL EXTERIOR PAINT FINISH.


POWER HOUSE



REPUBLIC OF THE PHILIPPINES  
DEPARTMENT OF AGRICULTURE  
REGIONAL FIELD OFFICE NO.5  
SAN AGUSTIN, PILI, CAMARINES SUR


PROJECT TITLE: <b>REPAIR OF POWER HOUSE</b>	PREPARED BY: <i>Arthur B. Mira</i> ARTHUR B. MIRA CAD - INPUT	CHECKED BY: <i>Jerry A. Eboña</i> ENGR. JERRY A. EBOÑA ERDSS/HEAD / A.E. III	SUBMITTED BY: <i>Silbert S. Salcedo</i> ENGR. SILBERT S. SALCEDO OIC-CHIEF,RAED	RECOMMENDING APPROVAL: <i>Luiz R. Marcelino</i> LUZ R. MARCELINO RTD FOR OPERATION	APPROVED BY: <i>Rodel P. Hornilla, Mabe</i> RODEL P. HORNILLA, MABE REGIONAL EXECUTIVE DIRECTOR	SHEET CONTENT: AS SHOWN ABOVE SHEET NO. 007/027
--	--	---	--	---	--	--



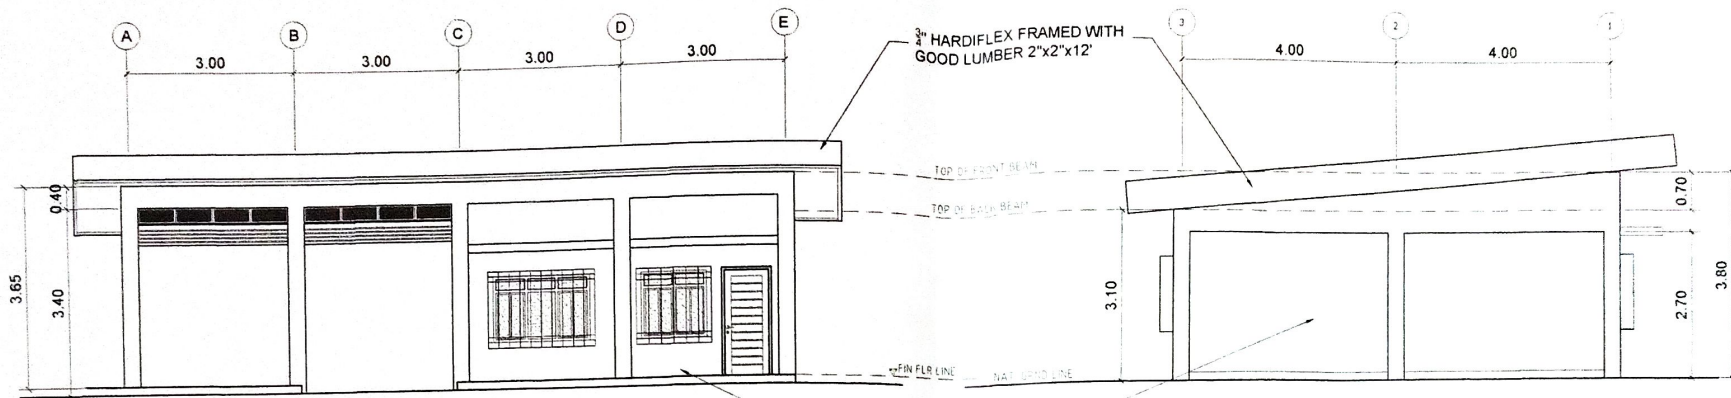


1  
A 2  
**FRONT ELEVATION**  
SCALE 1:100 M

2  
A 2  
**LEFT SIDE ELEVATION**  
SCALE 1:100 M

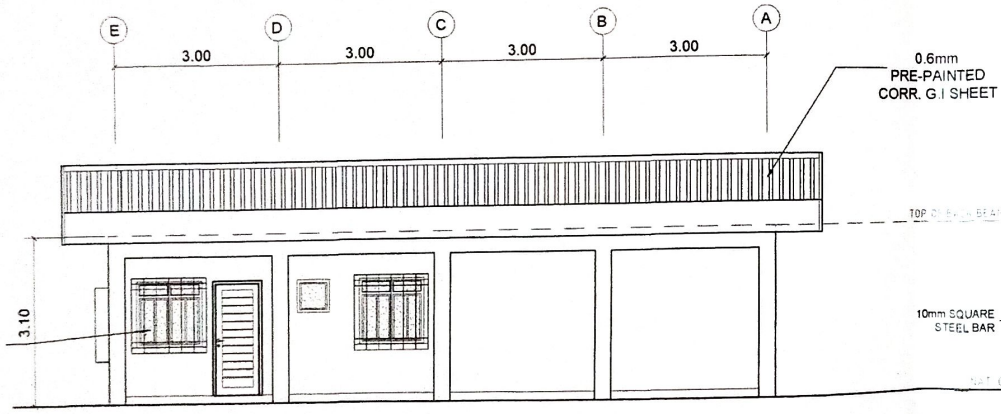

3  
A 2  
**REAR ELEVATION**  
SCALE 1:100 M

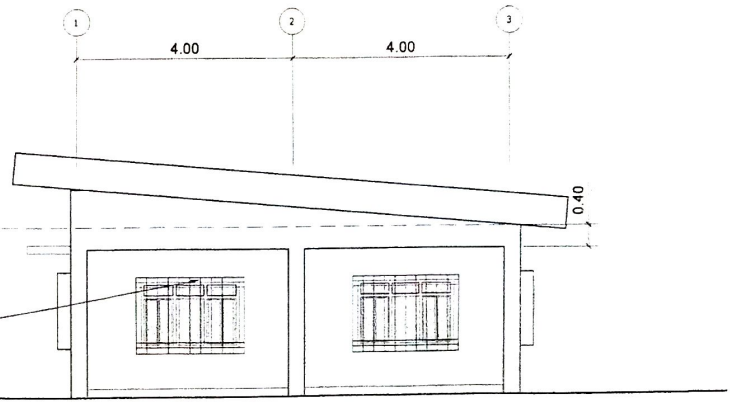

4  
A 2  
**RIGHT SIDE ELEVATION**  
SCALE 1:100 M



REPUBLIC OF THE PHILIPPINES  
DEPARTMENT OF AGRICULTURE  
REGIONAL FIELD OFFICE NO. 5  
SAN AGUSTIN, PILI, CAMARINES SUR

PROJECT TITLE:  
**REPAIR OF POWER HOUSE**  
SOURCE OF FUND:  
LOCATION: SDPTC, CABID-AN, SORSOGON CITY

PREPARED BY:  
*Arthur B. Mira*  
**ARTHUR B. MIRA**  
CAD - INPUT


CHECKED BY:  
*Jerry A. Eboña*  
**ENGR. JERRY A. EBOÑA**  
EFGS HEAD / A E III

SUBMITTED BY:  
*Gilbert S. Salcedo*  
**ENGR. GILBERT S. SALCEDO**  
OIC-CHIEF RAED


RECOMMENDING APPROVAL:  
*Luz R. Marcelino*  
**LUZ R. MARCELINO**  
RTD FOR OPERATION

APPROVED BY:  
*Rodel R. Tornilla, Mabe*  
**RODEL R. TORNILLA, MABE**  
REGIONAL EXECUTIVE DIRECTOR


SHEET CONTENT:  
**AS SHOWN ABOVE**  
SHEET NO.  
01/21/21

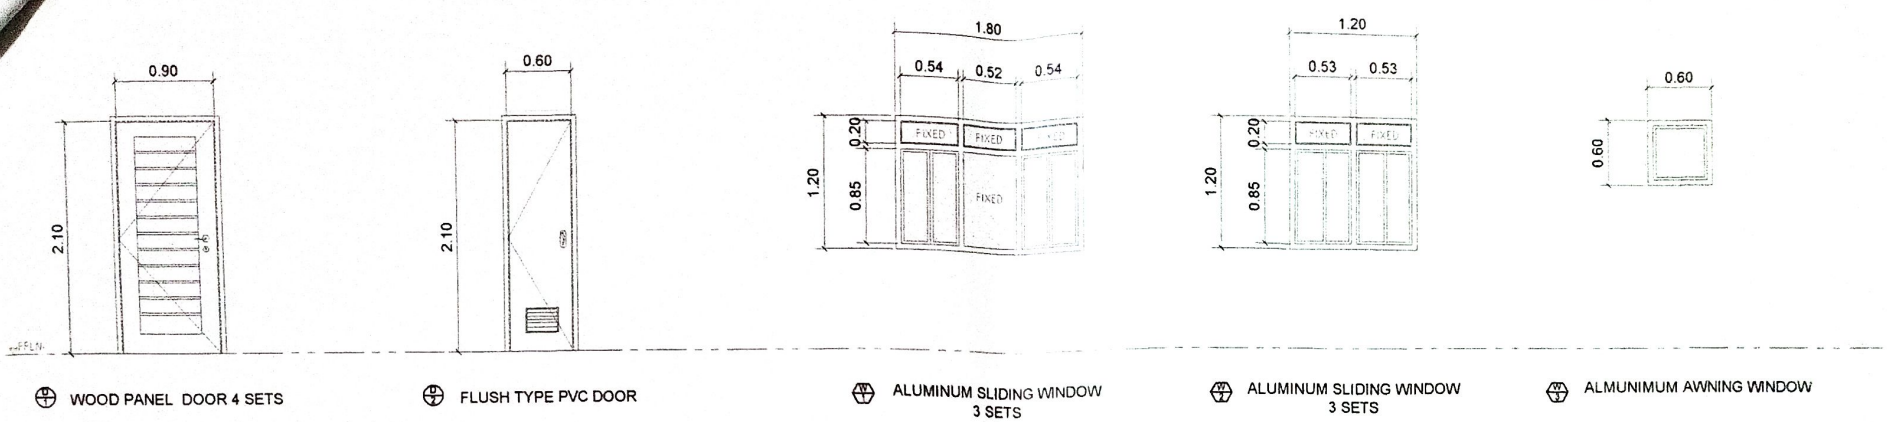

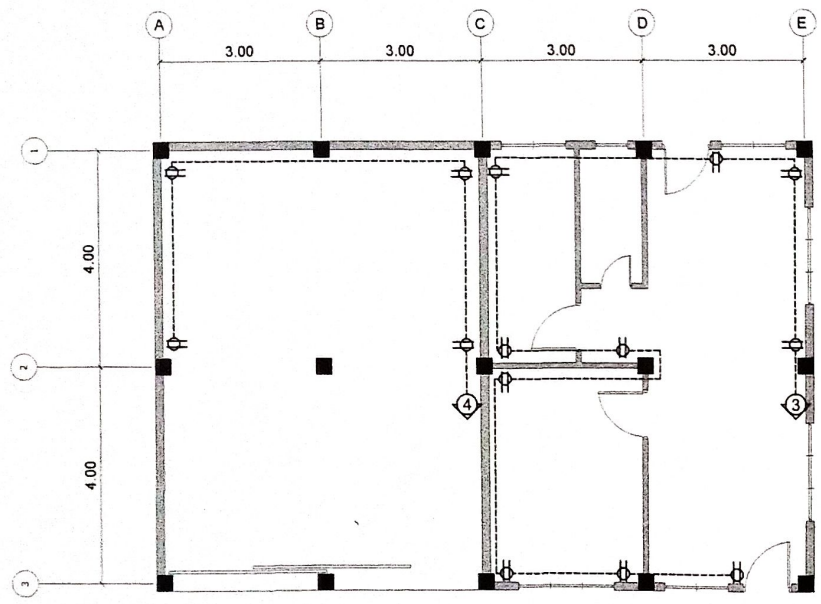



**1**  
A 3  
**SCHEDULE OF DOORS & WINDOWS**  
SCALE 1:50 M

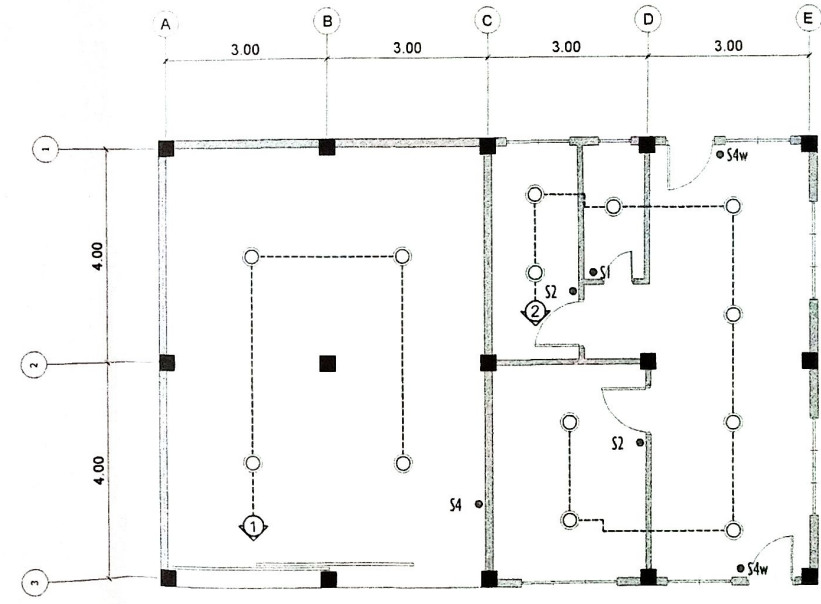

**2**  
A 3  
**POWER LAYOUT**  
SCALE 1:100 M



  **3**  
A 3  
**LIGHTING LAYOUT**  
SCALE 1:100 M

 REPUBLIC OF THE PHILIPPINES DEPARTMENT OF AGRICULTURE REGIONAL FIELD OFFICE NO.5 SAN AGUSTIN, PILI, CAMARINES SUR	PROJECT TITLE:	PREPARED BY:	CHECKED BY:	SUBMITTED BY:	RECOMMENDING APPROVAL:	APPROVED BY:	SHEET CONTENT:	
	<b>REPAIR OF POWER HOUSE</b>		 <b>ARTHUR B. MIRA</b> CAD - INPUT	 <b>ENGR. JERRY A. EBOÑA</b> EPDSS HEAD / A/E III	<b>ENGR. GILBERT S. SALCEDO</b> OIC-CHIEF RAED	<b>LUZ R. MARCELINO</b> RTD FOR OPERATION	 <b>RODEL R. TORMENTA, MABE</b> REGIONAL EXECUTIVE DIRECTOR	<b>AS SHOWN ABOVE</b> SHEET NO.
	SOURCE OF FUND:	LOCATION: SDPTC, CABID-AN, SORSOGON CITY						07/12/21